



6 Prints

SHASTA DIV'N.
DRAWING AGM 7606
SHEET NO. 1

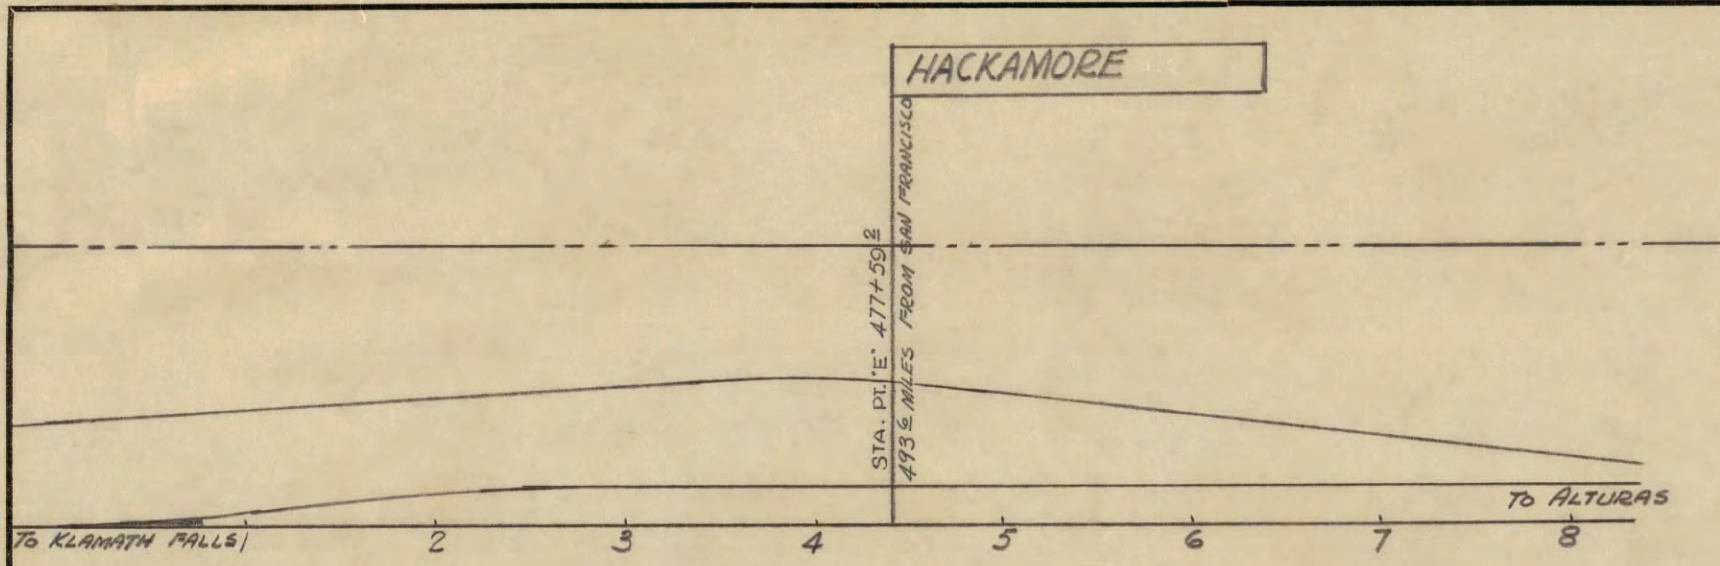

LEGEND

----- S.P. Co. R/W
 _____ YELLOW: FACILITIES TO BE RETIRED.

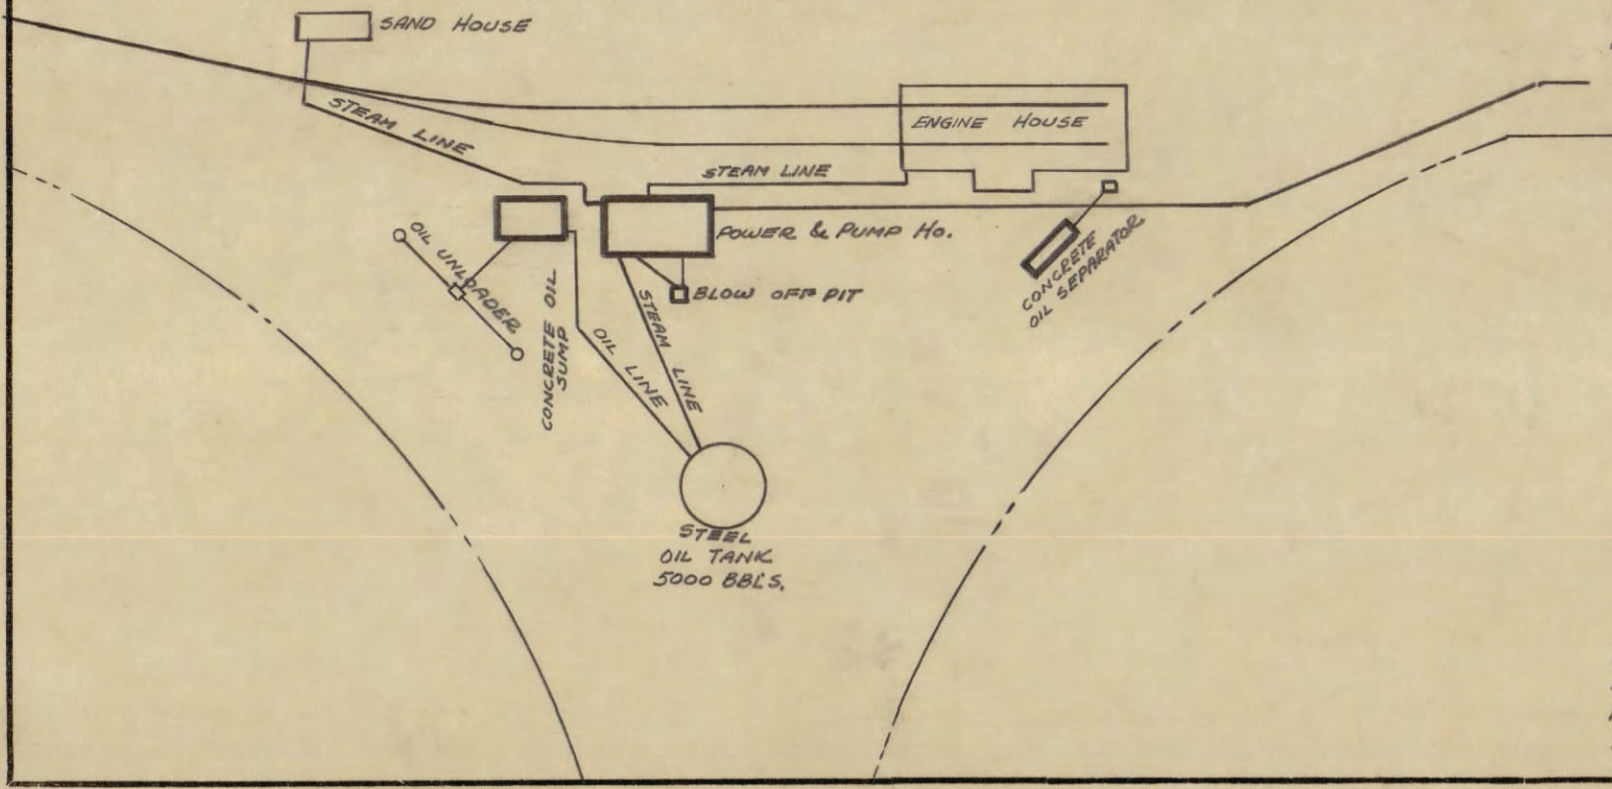

SOUTHERN PACIFIC COMPANY
 PACIFIC LINES
 HACKAMORE

RETIRE WATER & FUEL OIL FACILITIES, SAND HOUSE,
 POWER HOUSE, SAND DRYER & POWER PLANT
 MACHINERY, INCLUDING WATER, STEAM, OIL &
 POWER LINES.
 SCALE: 1"=100' MAY 1942

DRAWER